

**061070 - North Campus Infrastructure Project**  
 \* = Building Power Outages

**061080 - Site Improvements - MJ Dining Hall**

**061095 - Replace BAS - Academics**

**061096 - Construct New Facilities Storage Building**


**061119 - Rehab Corridor & Replace Bleachers - Merritt Pool**

**061120 - Replace Campus Entrance Signage**

**061016-02 - Sturges Hall Renovation**



**061125 - Replace Chiller - Saratoga Heating Plant**

- Building Key**
- 2 - James B. Welles Hall
  - 3 - Doty Hall
  - 5 - Walter E. Lauderdale Health
  - 6 - James V. Sturges Hall
  - 7 - Carl L. Schrader Physical Ed.
  - 8 - Wadsworth Auditorium
  - 9 - Bertha Paine Fraser Hall
  - 10 - Heating Plant
  - 11 - Blake Hall A, B & C
  - 12 - Livingston Residence Hall
  - 13 - Lydia I. Jones Residence Hall
  - 14 - Monroe Residence Hall
  - 15 - Mary Jemison Dining Hall
  - 16 - George A. Bailey Hall
  - 17 - Clark Service Building
  - 18 - Presidents House
  - 22 - Steuben Residence Hall
  - 23 - Wyoming Residence Hall
  - 24 - Genesee Residence Hall
  - 25 - Letchworth Dining Hall
  - 26 - Allegany Residence Hall
  - 27 - Ontario Residence Hall
  - 28 - Erie Residence Hall
  - 29 - Wm. S. & John M. Milne Library
  - 30 - George D. Newton Lecture Hall
  - 31 - Austin W. Erwin Administration
  - 31A - Roemer House
  - 32 - William A. Brodie Fine Arts
  - 33 - Nassau Residence Hall
  - 34 - Suffolk Residence Hall
  - 35 - Red Jacket Dining Hall
  - 36 - Transformer Building
  - 38 - Robert W. MacVittie Union
  - 39 - Wayne Residence Hall
  - 40 - Onondaga Residence Hall
  - 41 - Niagara Residence Hall
  - 42 - Myrtle A. Merritt Athletic Center
  - 43 - Storage Building
  - 45 - Commons
  - 46 - South Hall
  - 48 - Saratoga Terrace
  - 49 - Putnam Residence Hall
  - 50 - Integrated Science Center
  - 51 - Greenhouse
  - 52 - Seneca Hall
  - 53 - Hazardous Storage
  - 54 - Saratoga Heating Plant
  - 55 - Stadium - North Bldg.
  - 56 - Stadium - Grandstand/Pressbox
  - 57 - Stadium - South Bldg.
  - 58 - Stadium - Pressbox

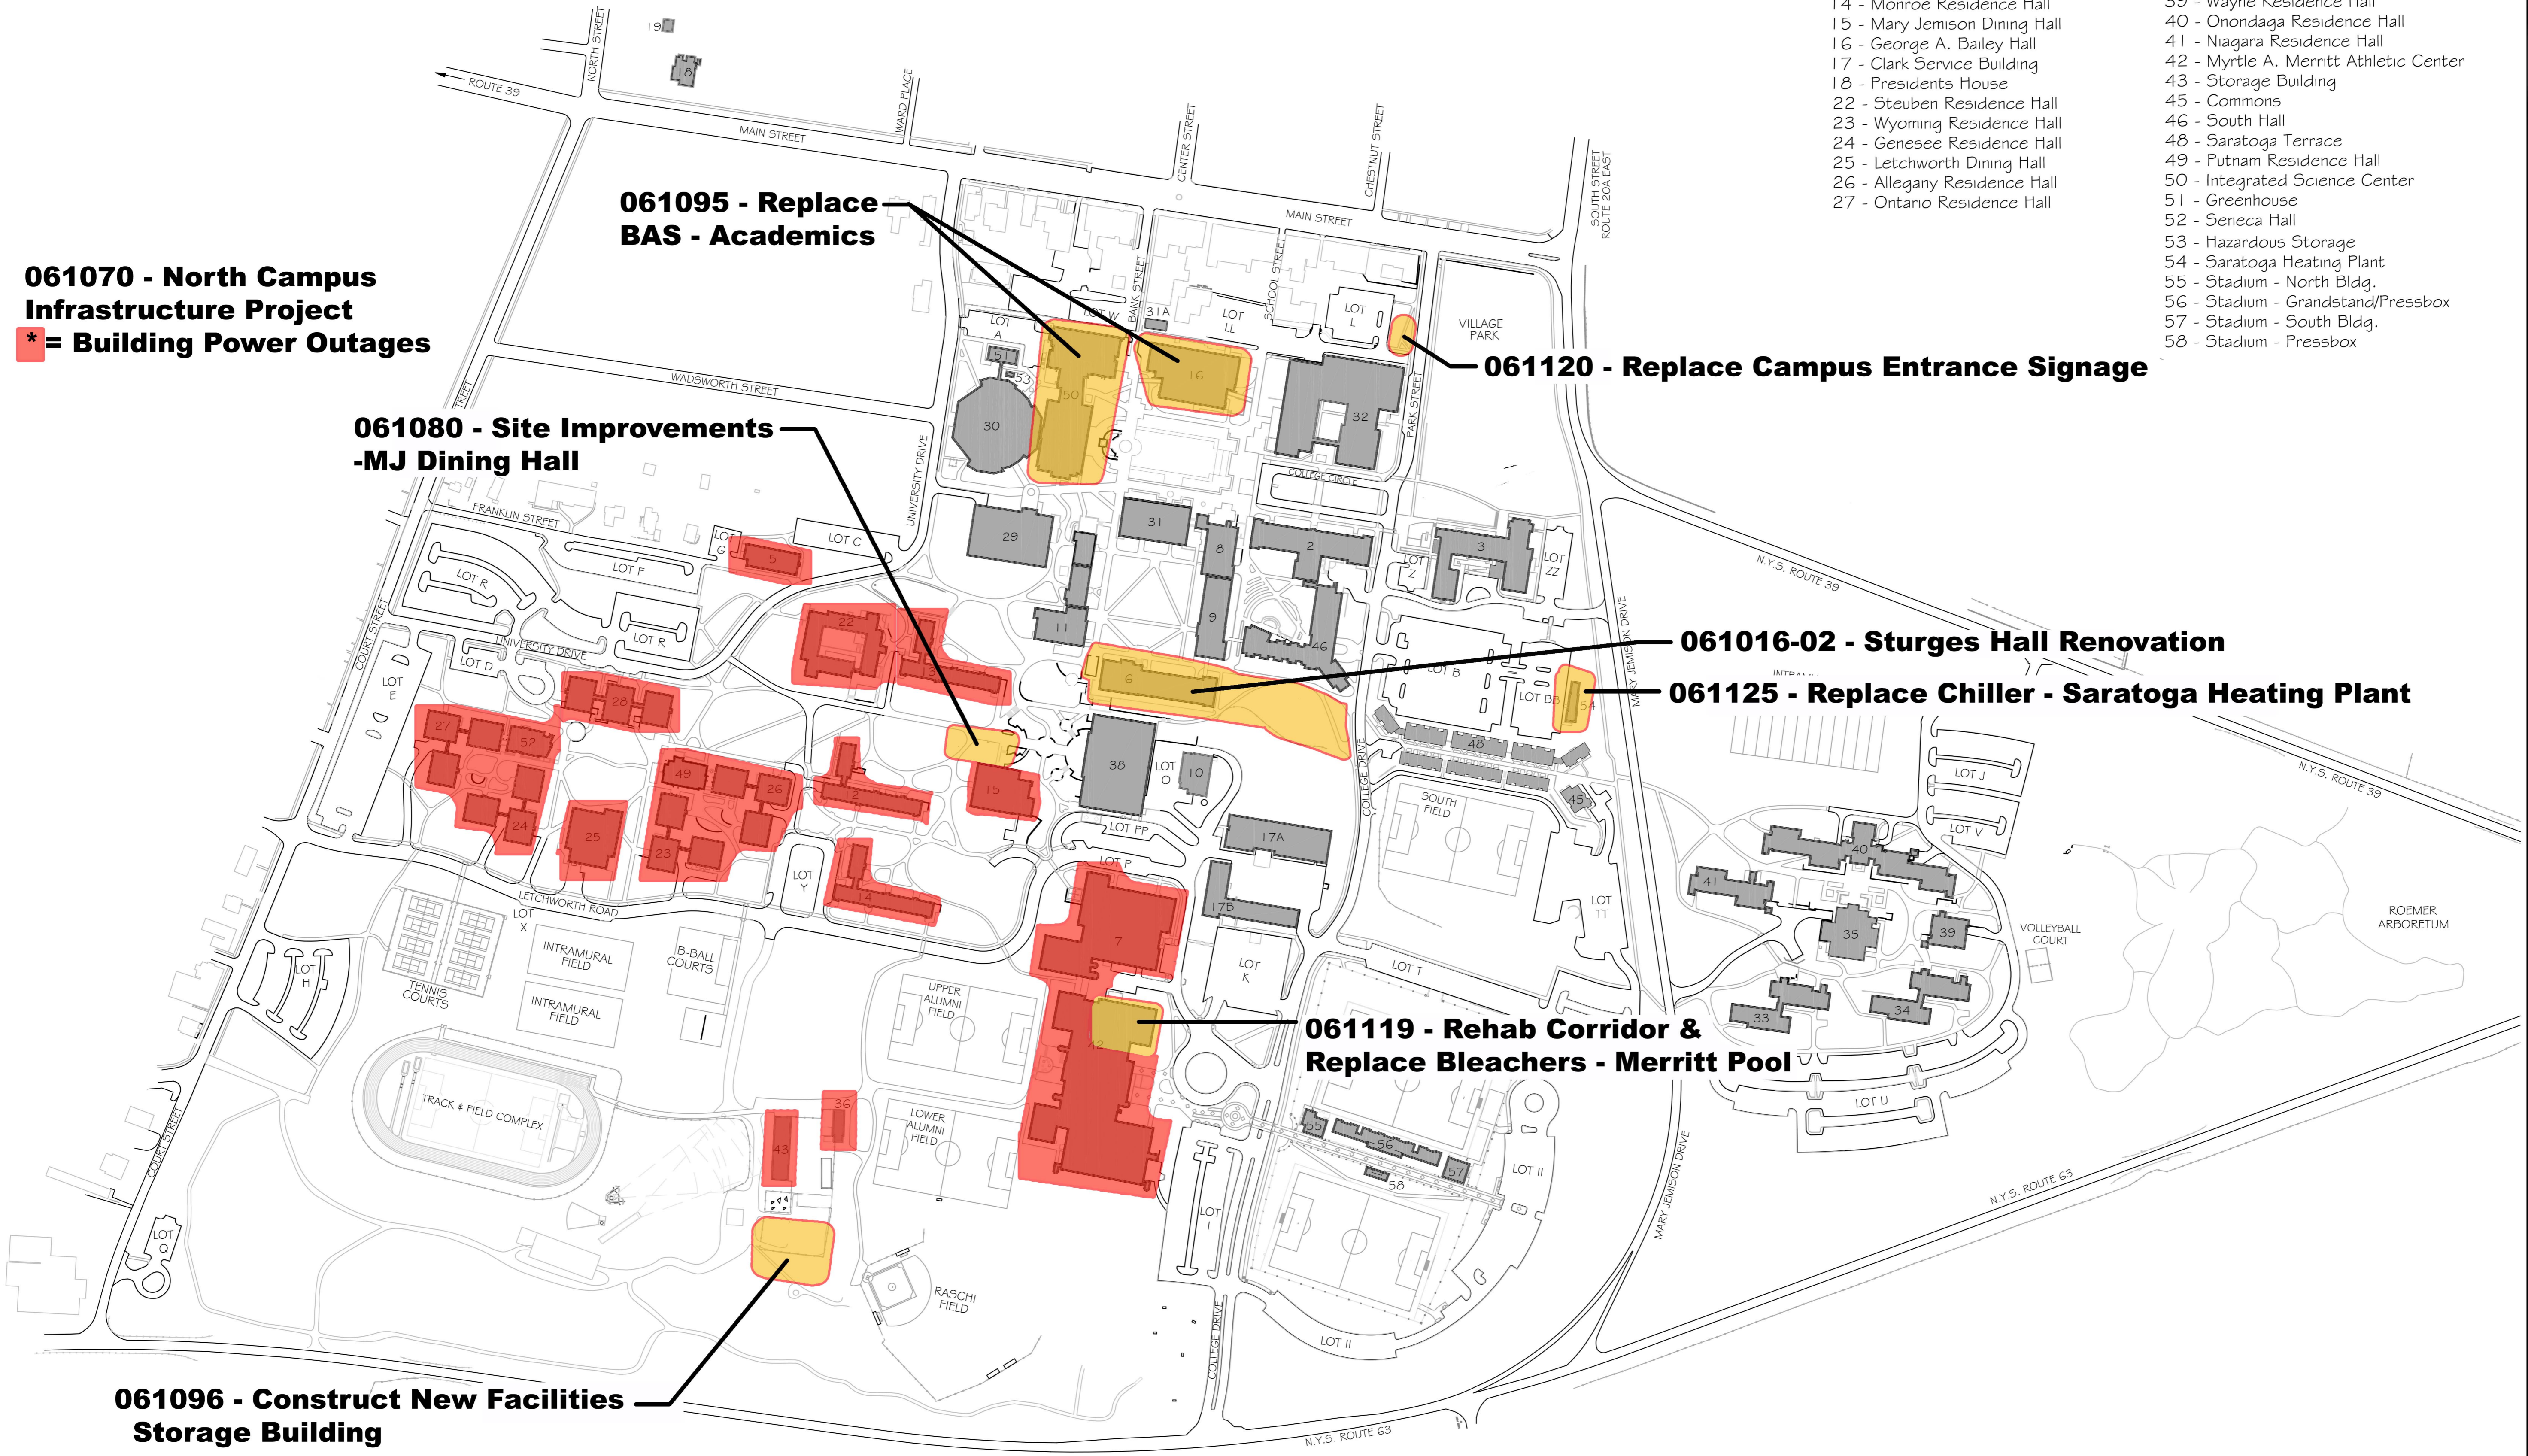

**GENESEE**

 **2026 SUMMER CONSTRUCTION PROJECTS**

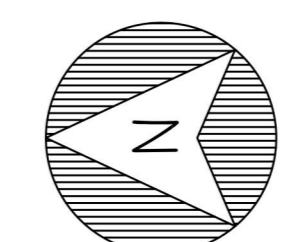

No.	Revision/Issue	Date

Project Name  
**Revised 4/15/2026**

Drawing Title  
**Campus Map**

Project No.	Sheet
Date	1
Scale	1" = 200'